


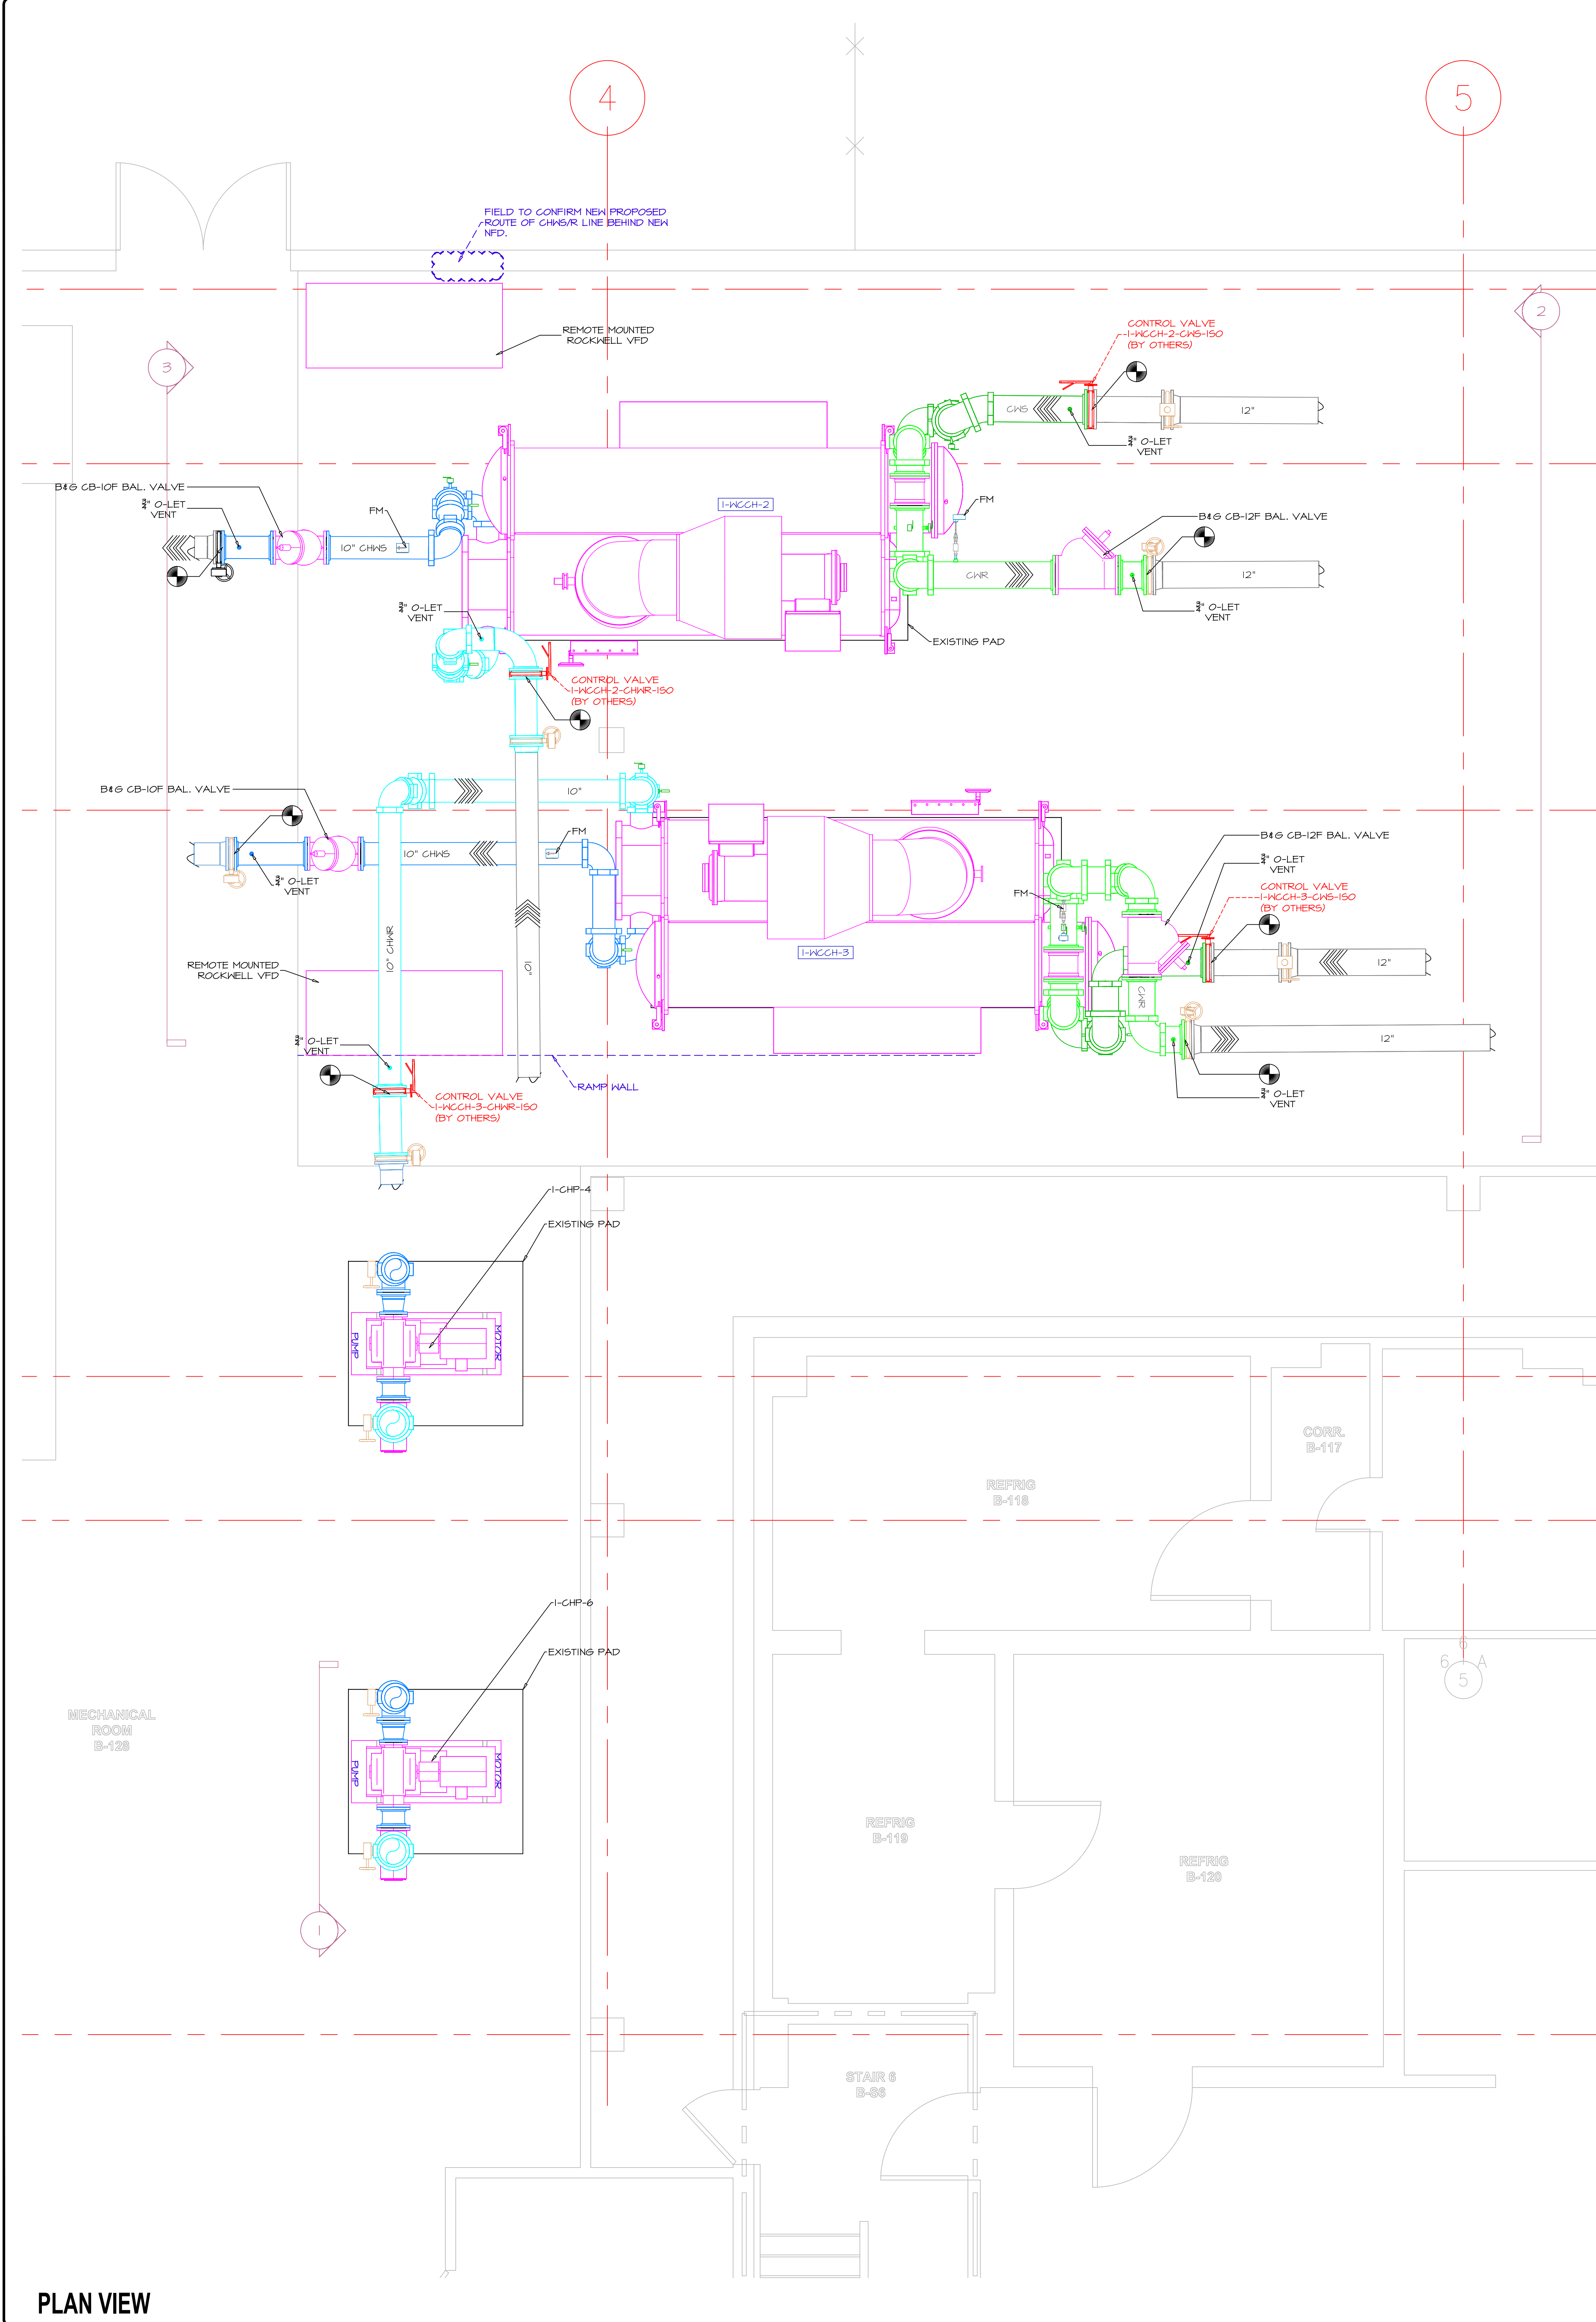
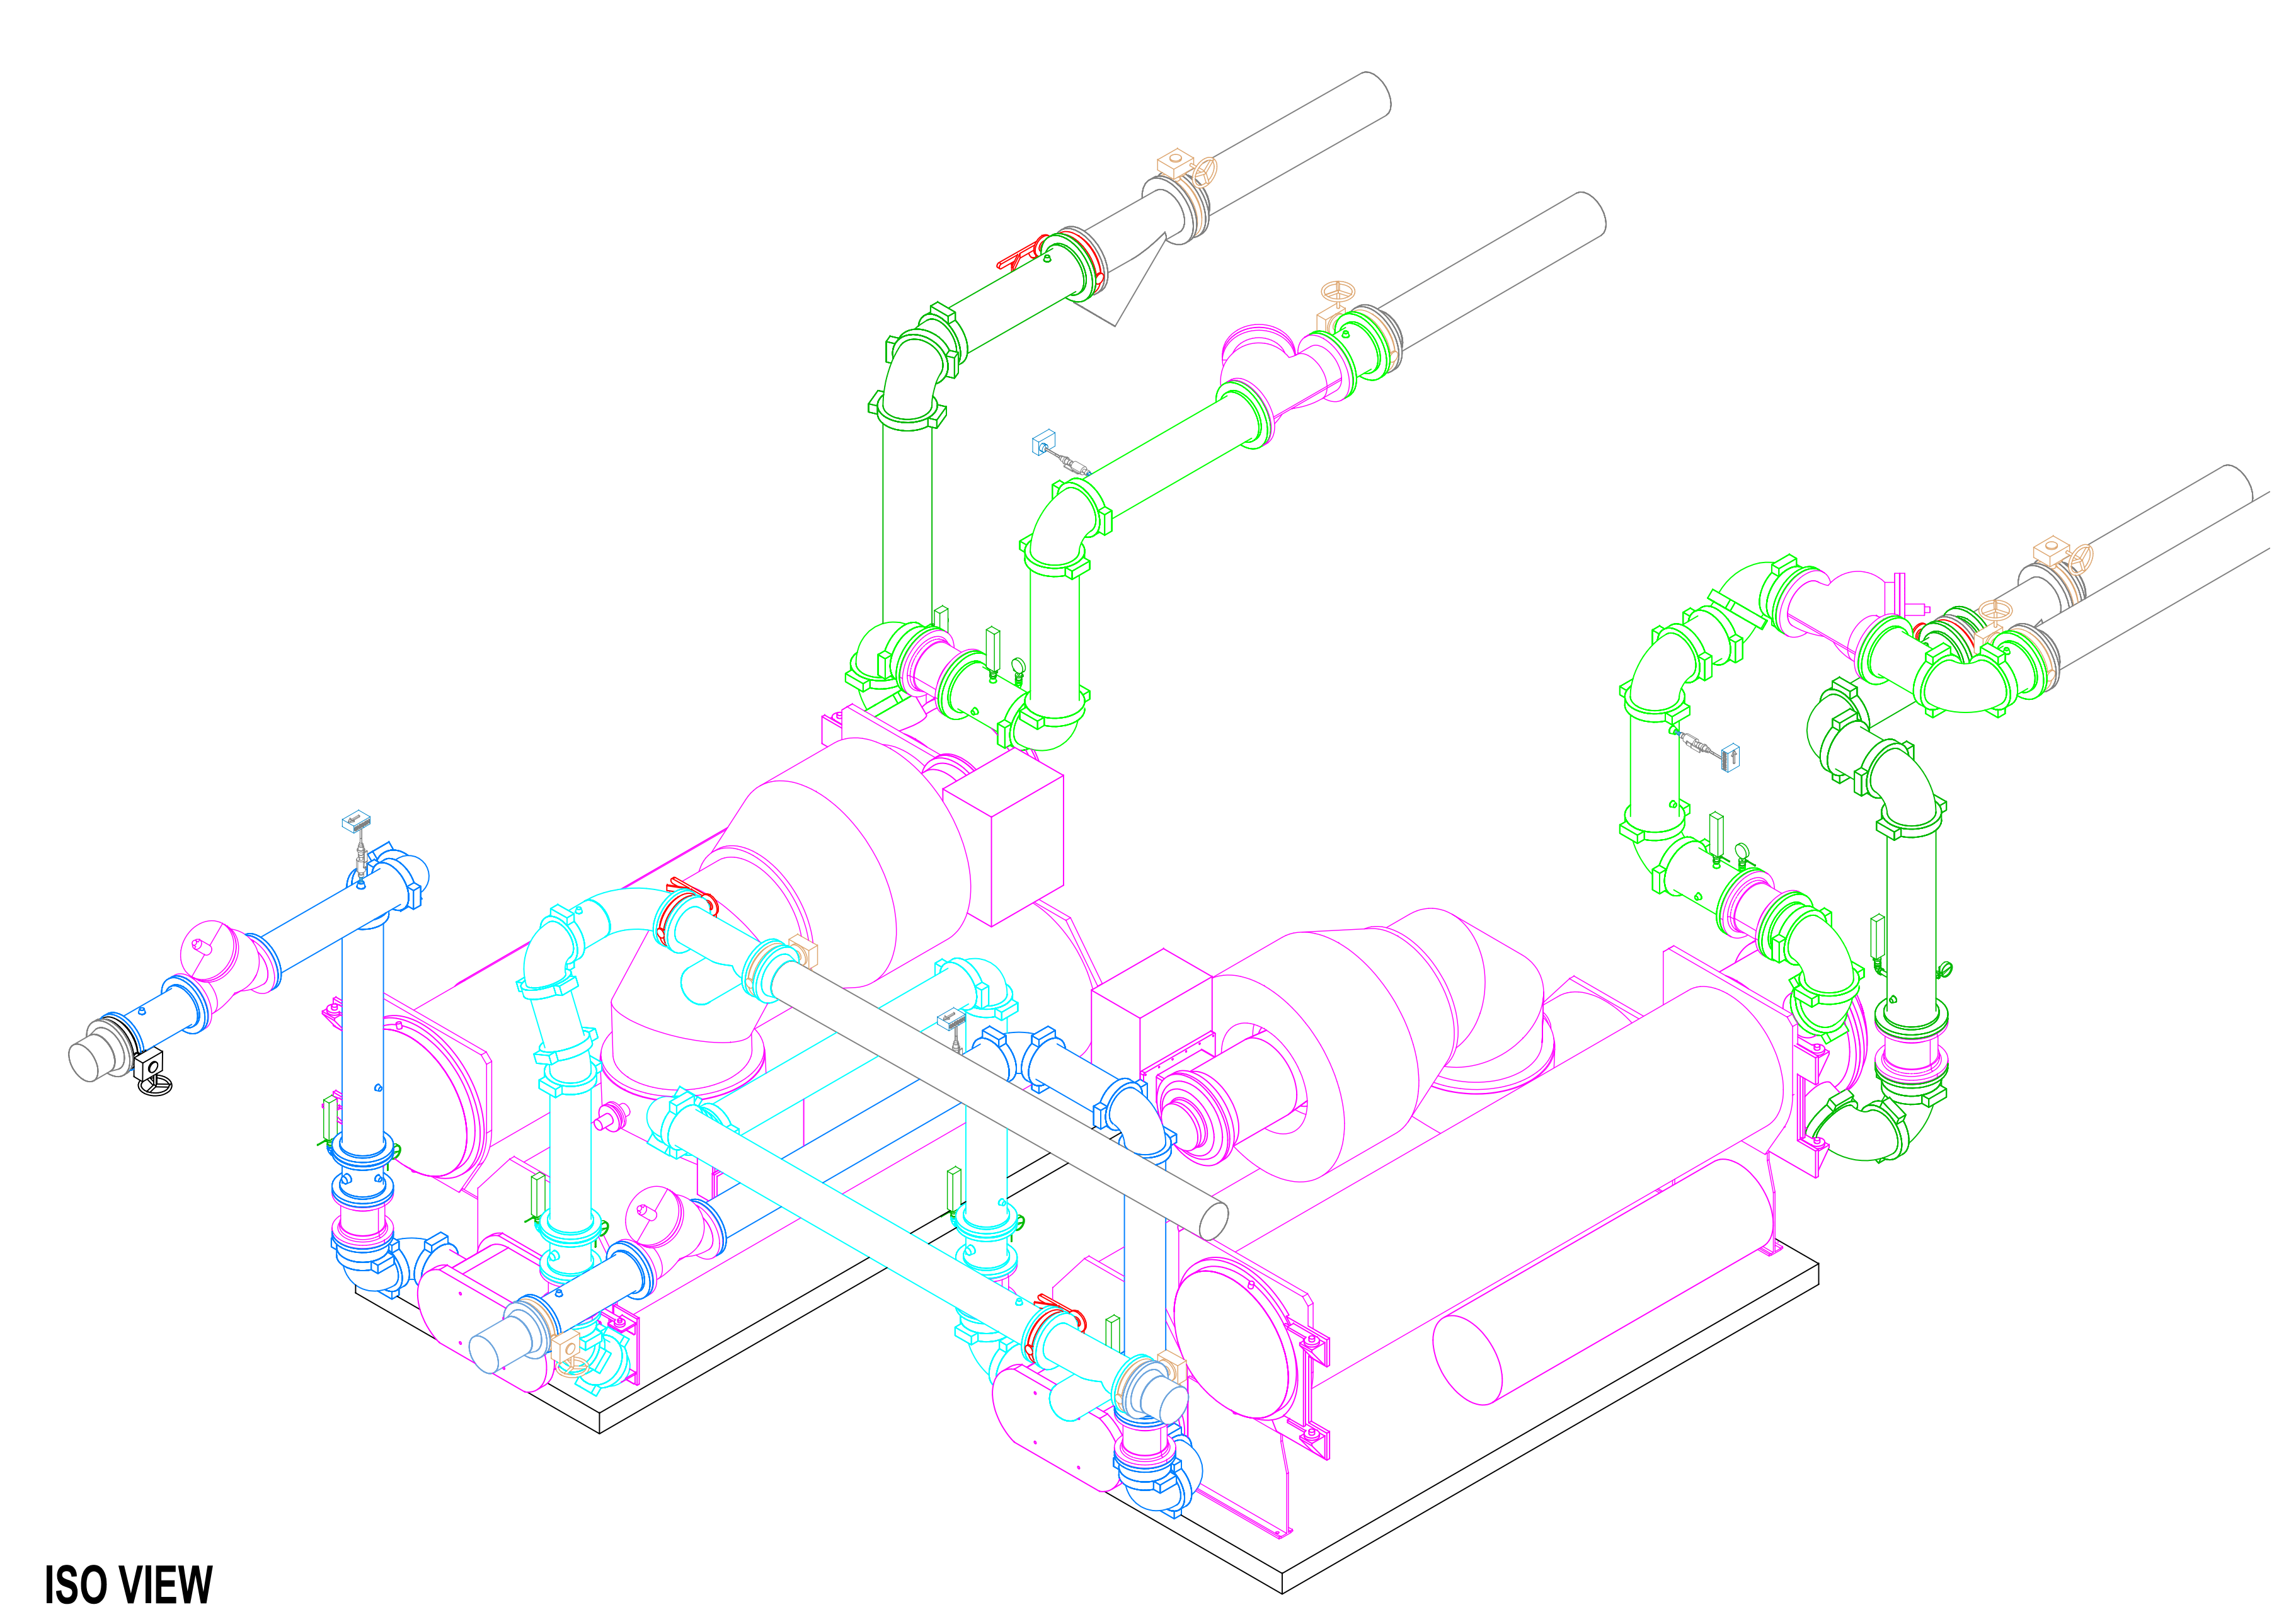


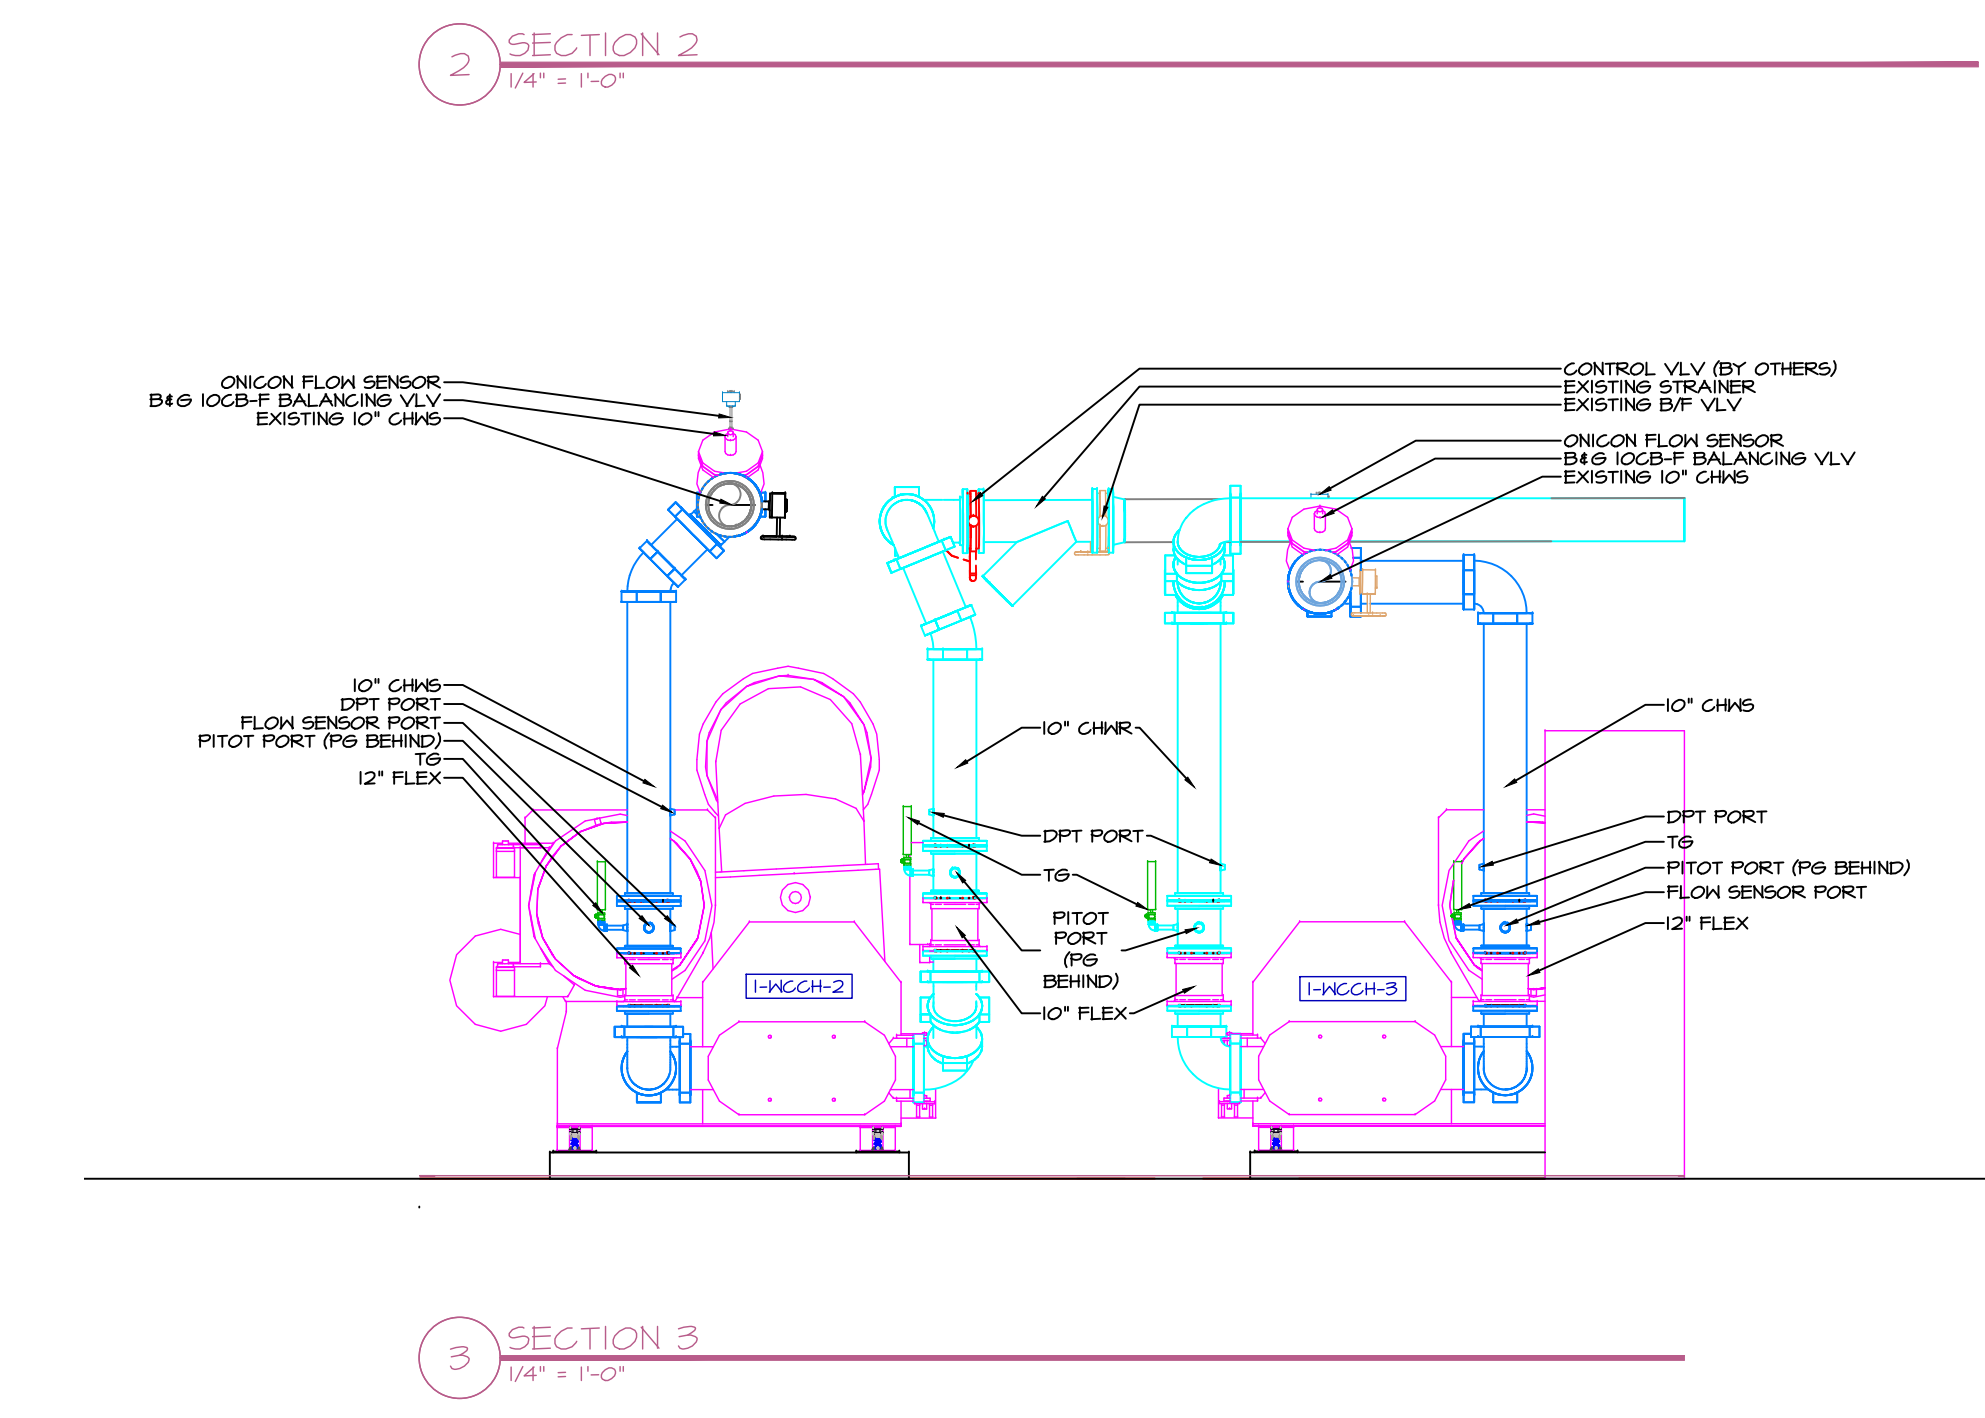

PLAN VIEW

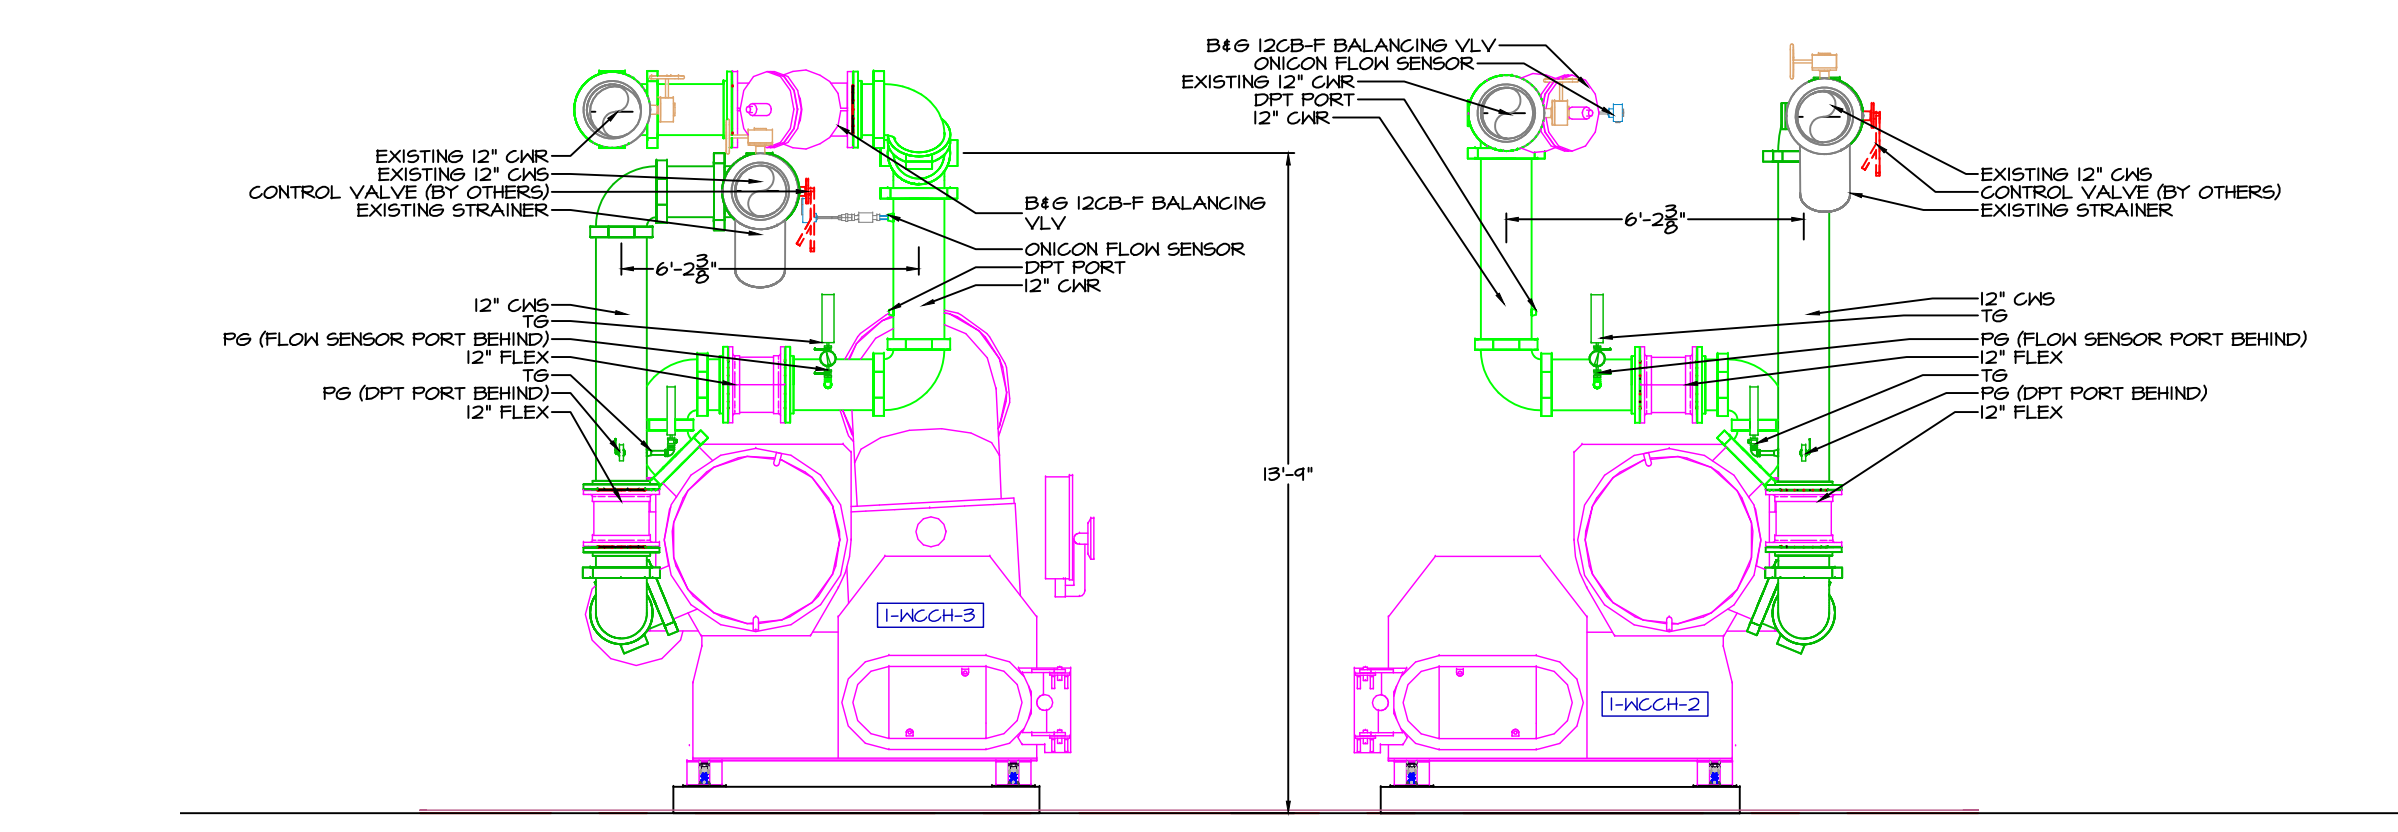

ISO VIEW

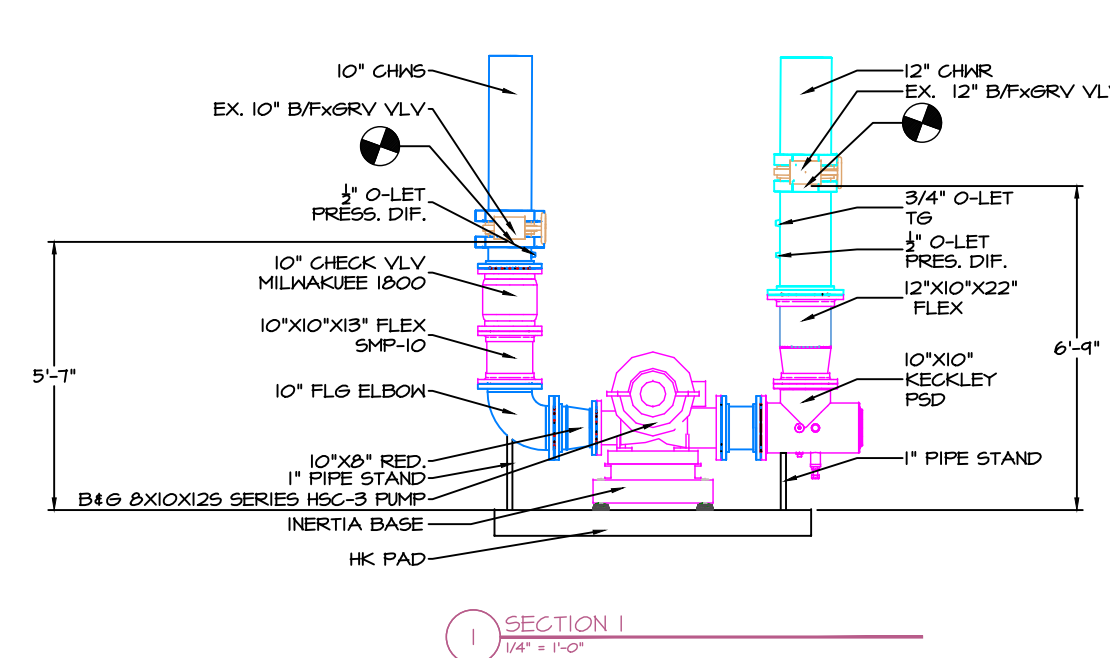

DESIGNER - DETAILER

3D EDGE LLC
1500 N. 9th St. Suite 100
Tomball, TX 77375
Tel: 281.350.0000
Fax: 281.350.0001
www.3dedge.com

CONTRACTOR - CLIENT

ALL STATES MECHANICAL, LTD.

GENERAL PROJECT NOTES

1. SUPPLY PIPES AT EX. TIE-IN LOCATIONS ARE TO BE SHIPPED LOOSE FOR PROPER ALIGNMENT.

REVISIONS

NO.	DATE	DESCRIPTION
1		
2		
3		
4		
5		
6		
7		
8		
9		

PROJECT NAME & ADDRESS

EAST ORANGE VAMC
REPLACEMENT BOTH 400-TON CHILLERS
VA EAST ORANGE CAMPUS

DRAWING STATUS & DATE

STATUS	DATE
COORDINATION/REVIEW	8-17-21
SUBMITTAL	8-17-21
RESUBMITTAL	-
RECORD	-
FIELD SET	-
AS-BUILT	-

KEY PLAN

HEIGHTS BASED OFF STRUCTURAL SLAB U.G.D.

TAG LEGEND:
TOP: C/L OF PIPE
TOP: TOP OF PIPE
BRI: BOT. OF INSUL.
BOP: BOT. OF PIPE
TOS: TOP OF STEEL

ORIGINAL SIZE: 21'-0" x 21'-0"
DATE: 6/30/21
SCALE: 3/8"=1'-0"
SHEET FILE: M-100

DESIGNED BY: PM
CHECKED BY: PM
APPROVED BY: PM

400 CHILLER AND PUMP
PIPING LAYOUT

SHEET NO. M-100